

WINDOW SCHEDULE


MARK	GEN. DESCRIPTION	MANUFACTURER	CAT #	ROUGH WIDTH	ROUGH HEIGHT	NOTES
A	DOUBLE HUNG	INTEGRITY	ITDH 3648	MO = 36"	MO = 48"	WOOD ULTRIX SERIES
B	AWNING	INTEGRITY	IAWN 3319	MO = 32.5"	MO = 19.75"	WOOD ULTRIX SERIES
C	DOUBLE HUNG	INTEGRITY	ITDH 2240	20.5	40.25	STILL-HT. 40" +/-
D	DOUBLE HUNG	INTEGRITY	ITDH-X FIELD	APPROX 28"	APPROX 37"	FIELD VERIFY FOR REPLACEMENT WINDOW IN EXIST. 096.
E	DOUBLE HUNG	INTEGRITY	ITDH-X FIELD	APPROX 28"	APPROX 49"	PAIR - FIELD VERIFY FOR REPLACEMENT WINDOW IN EXIST. 096.
F	CASEMENT ABOVE SINK	INTEGRITY	ICAM 1735 2W	33	33.75	
G	DOUBLE HUNG	INTEGRITY	ITDH-X FIELD	APPROX 28"	APPROX 49"	PAIR - FIELD VERIFY FOR REPLACEMENT WINDOW IN EXIST. 096.
H	LIVING RM. FIXED PICTURE W/ FLANKERS	INTEGRITY	ITDH-X FIELD	TOTAL APPROX 116"	TOTAL APPROX 61"	FIELD VERIFY FOR REPLACEMENT WINDOW IN EXIST. 096.
I	DOUBLE HUNG	INTEGRITY	ITDH-X FIELD	APPROX 28"	APPROX 37"	FIELD VERIFY FOR REPLACEMENT WINDOW IN EXIST. 096.
J	ATTIC GABLE DOUBLE HUNG	INTEGRITY	ITDH 2648	26.5	48.25	STILL-HT. 38" +/-
K	TOWER - DOUBLE HUNG	INTEGRITY				
L	AWNING	INTEGRITY				
M	GARAGE - DOUBLE HUNG	INTEGRITY				
N	GLIDING - EGRESS WINDOW	INTEGRITY	IT6L 4848	48.5	48.5	EGRESS STILL-HT. 43.75" +/-

NOTES

- SKYLIGHTS SHALL BE SUPPLIED WITH "LAMINATED SAFETY GLASS", PROVIDE VELUX, DECK OR COMB. MOUNTED, REMOTE CONTROL, ELECTRIC VENTING MODEL 101 USE, 21.5" W. x 27.5" H.
- ALL WINDOWS SHOWN ARE INTEGRITY "WOOD ULTRIX" FIBERGLASS SERIES
- WINDOWS ADJACENT TO MASTER BATH TUB SHALL HAVE TEMPERED SAFETY GLASS
- PROVIDE ALL OPERATING UNITS WITH MANUFACTURER'S STANDARD INSECT SCREENS
- OPTION - FIELD MEASURE EXIST. BASEMENT AWNING WINDOWS FOR REPLACEMENT WITH NEW AWNING UNITS
- VERIFY WITH OWNER FOR INTERIOR WOOD TYPE, INTERIOR FINISH, AND HARDWARE FINISH
- ALL MULLIONS SHALL BE "BETWEEN THE GLASS", SEE ELEVATION DRAWINGS FOR MULLION PATTERNS
- SEE OWNER FOR EXTERIOR COLOR OF WINDOWS. SELECT FROM MFG'S STANDARD
- ALL UNITS SHALL BE "ENERGY STAR" RATED, MAX. U-FACTOR 0.40, (0.35 PREFERRED) ALL GLAZING SHALL BE "LOW E-IT" ARGON GAS FILLED

1
12

SECOND FLOOR ELECTRICAL PLAN

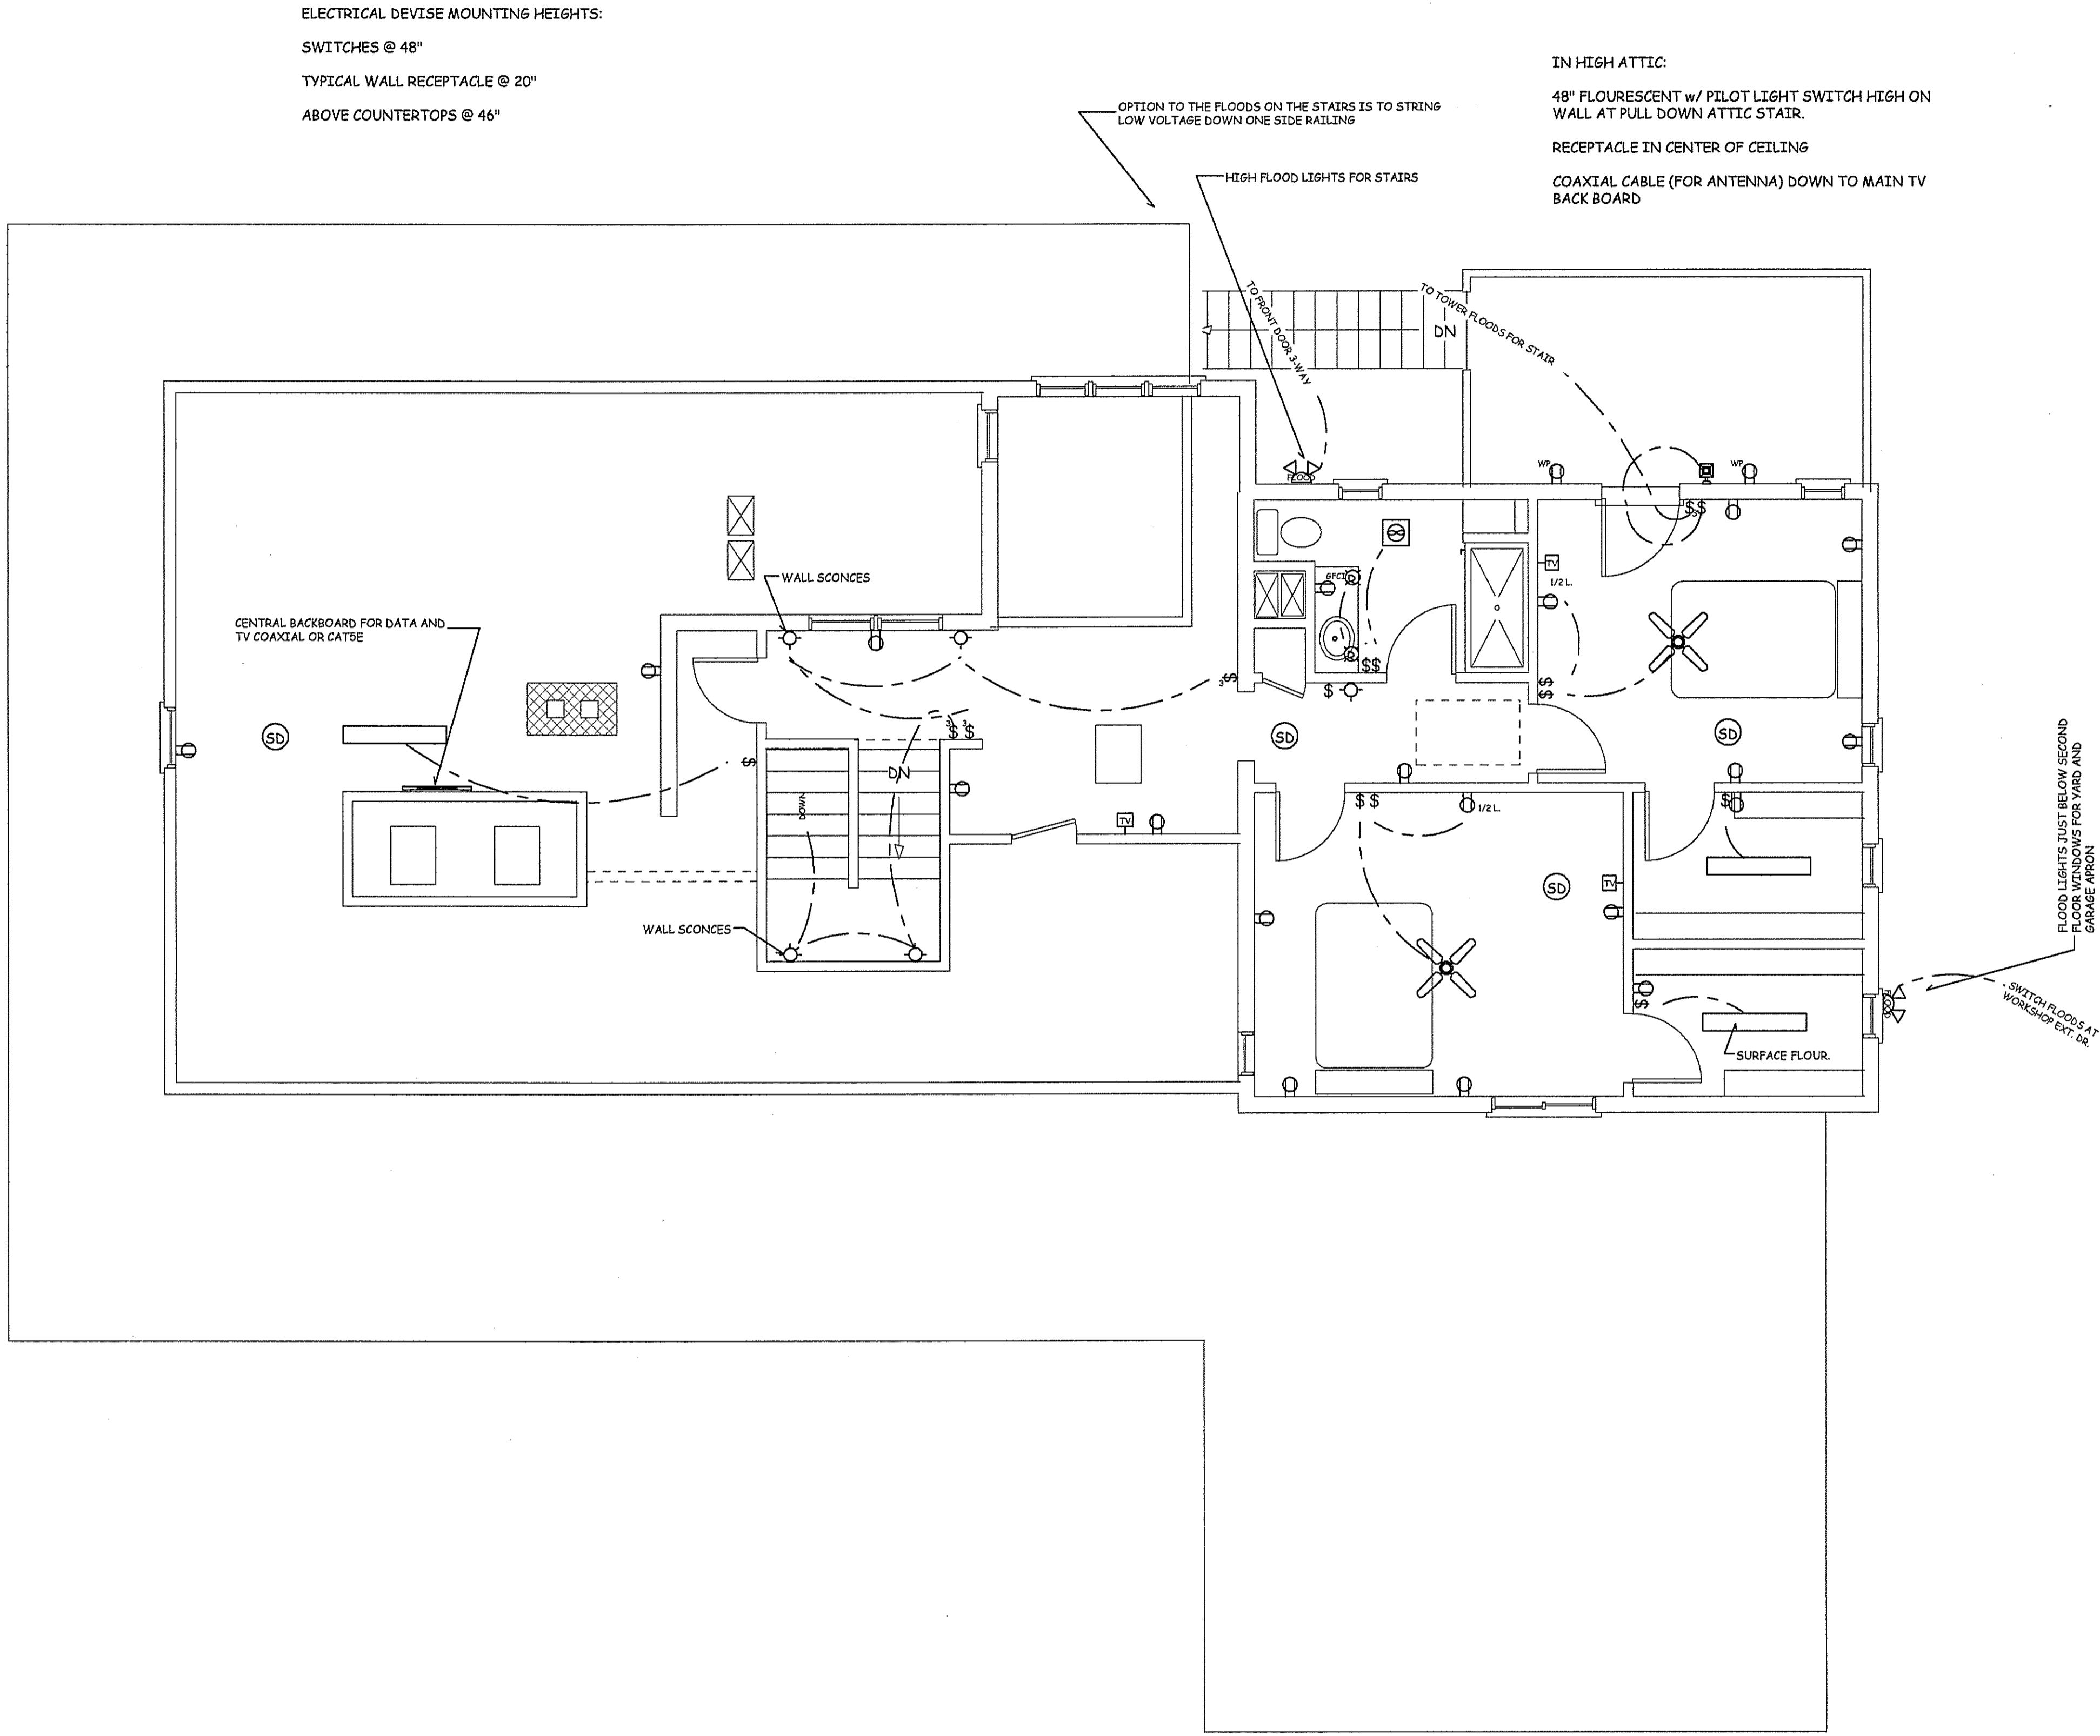

ELECTRICAL DEVICE MOUNTING HEIGHTS:
 SWITCHES @ 48"
 TYPICAL WALL RECEPTACLE @ 20"
 ABOVE COUNTERTOPS @ 46"

IN HIGH ATTIC:
 48" FLOURESCENT w/ PILOT LIGHT SWITCH HIGH ON WALL AT PULL DOWN ATTIC STAIR.
 RECEPTACLE IN CENTER OF CEILING
 COAXIAL CABLE (FOR ANTENNA) DOWN TO MAIN TV BACK BOARD

SECOND FLOOR ELECTRICAL PLAN

505 ROCKSVILLE ROAD
 ADDITIONS & RENOVATIONS
 for Jack and Joanna Pitula
 Northampton Twp, Bucks County, PA

PM Group
 General Construction
 2908 Marlon Ave.
 Bensalem, PA 19020
 215-245-3572
 pmgroupfu@nestscape.net

creative design A sociates, Inc.
 ARCHITECTURE INTERIORS SITE & SPACE PLANNING
 2 South York Road, 2-A
 Hatboro, PA 19040
 215-672-1155
 www.Architectvision.com

VALID FOR PERMITS ONLY IF IMPRESSED WITH ORIGINAL SEAL & ORIGINAL SIGNATURE IN "RED"

REV. #	REVISION DESCRIPTION	DATE
	PROJECT START UP FOR PERMITS	OCT. 25, 2007
	PER. PERMIT REVIEW	MAY 01, 2008
		5-23-08

Sheet No.
12
 Comm. No.
 07-2875 of 12