



CRAWLSPACE DEHUMIDIFICATION: BOTH TENANT SPACES
 REMOVE AND FILL ALL EXISTING WINDOWS OR VENTS. USE SAME MATERIALS, INTERIOR TREATMENTS, AND INSULATION (IF ANY).
 INSTALL A GOOD QUALITY RESIDENTIAL DEHUMIDIFIER AS CENTRAL AND HIGH AS PRACTICAL IN SPACE, WITH HOSE DISCHARGE TO COMMERCIAL CONDENSATE PUMP WITH FLOAT.
 MOUNT PUMP SECURELY, AND HARD PLUMB DISCHARGE TO ONE OF THE NEW PVC SLEEVES.
 CONTROLS: INSTALL A GOOD SEPARATE, ADJUSTABLE, HUMIDISTATE.

4
2 FOUNDATION PLAN

THIS PROJECTS WORK IS MOSTLY EXTERIOR REPAIRS.
 BUILDING INTERIOR INFORMATION SHOWN IS TAKEN FROM THE ORIGINAL CONSTRUCTION DOCUMENTS WHICH ARE 20 YEARS OLD, THE CURRENT LAYOUT HAS NOT BEEN SURVEYED OR VERIFIED.
 THIS IS PROVIDED FOR FUTURE PLANNING PURPOSES ONLY.

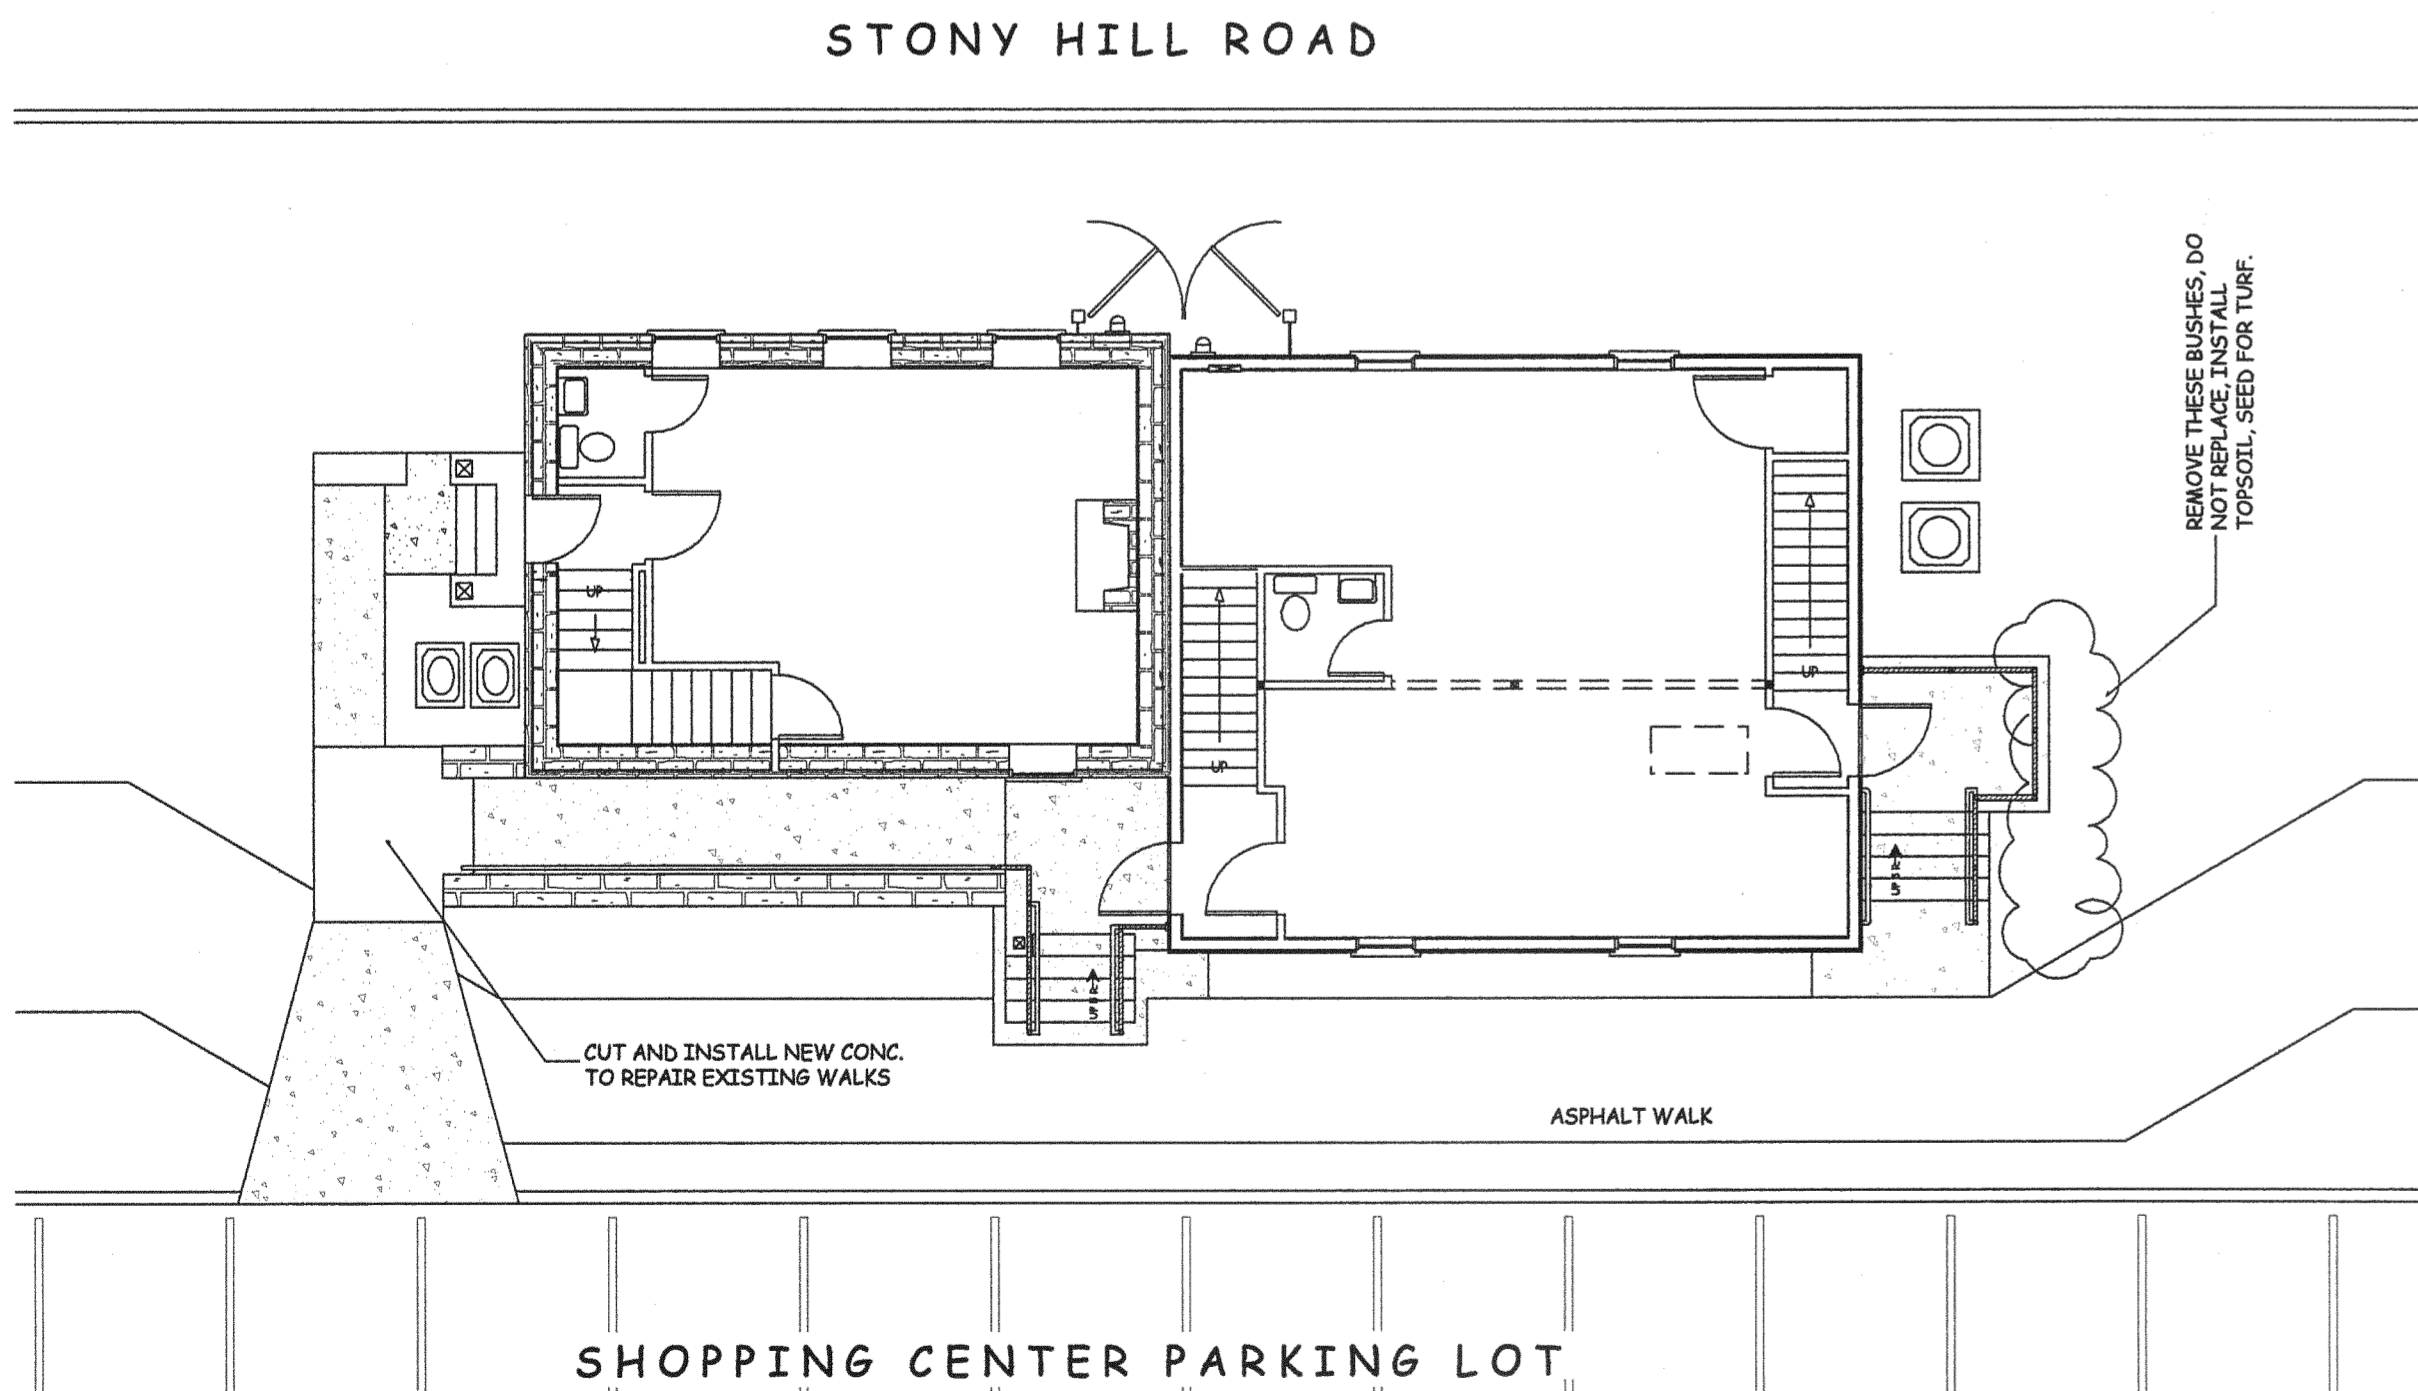


1
2 IMMEDIATE SITE AT WARREN FARRINGER HOUSE ONLY
 SCALE: 1/8" = 1'-0"

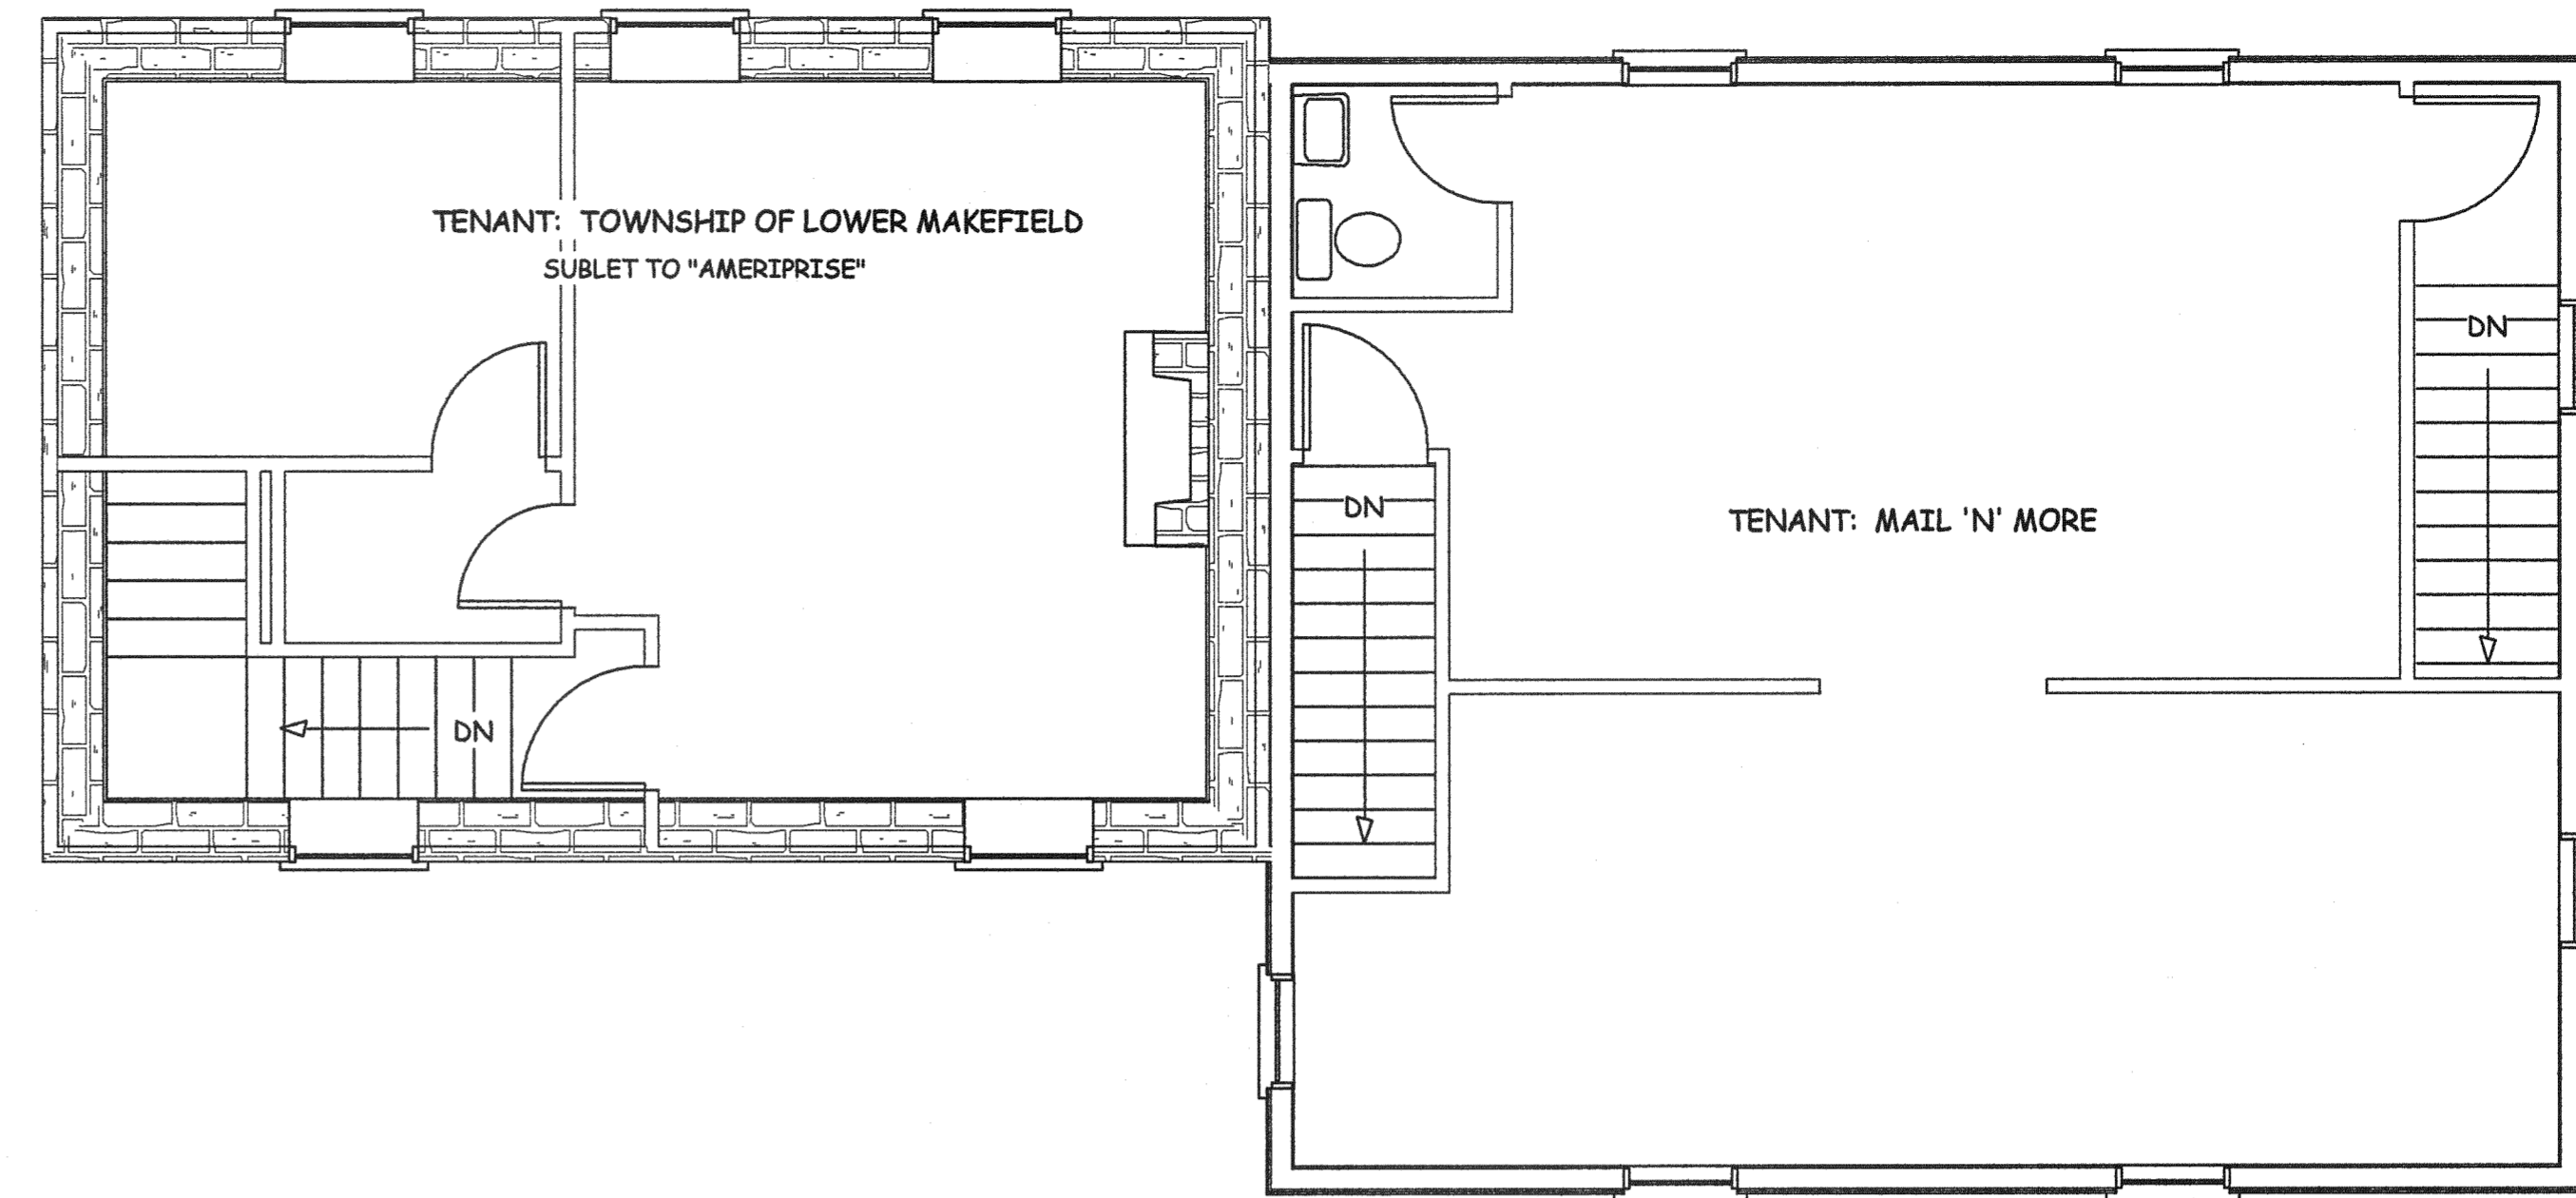

SEE NOTES AND SPECIFICATIONS, PAGE 5

SECOND FL. HVAC IS IN ATTIC, WITH DUCTWORK FOR SECOND FL. ONLY

3
2 SECOND FLOOR PLAN
 SCALE: 1/4" = 1'-0"

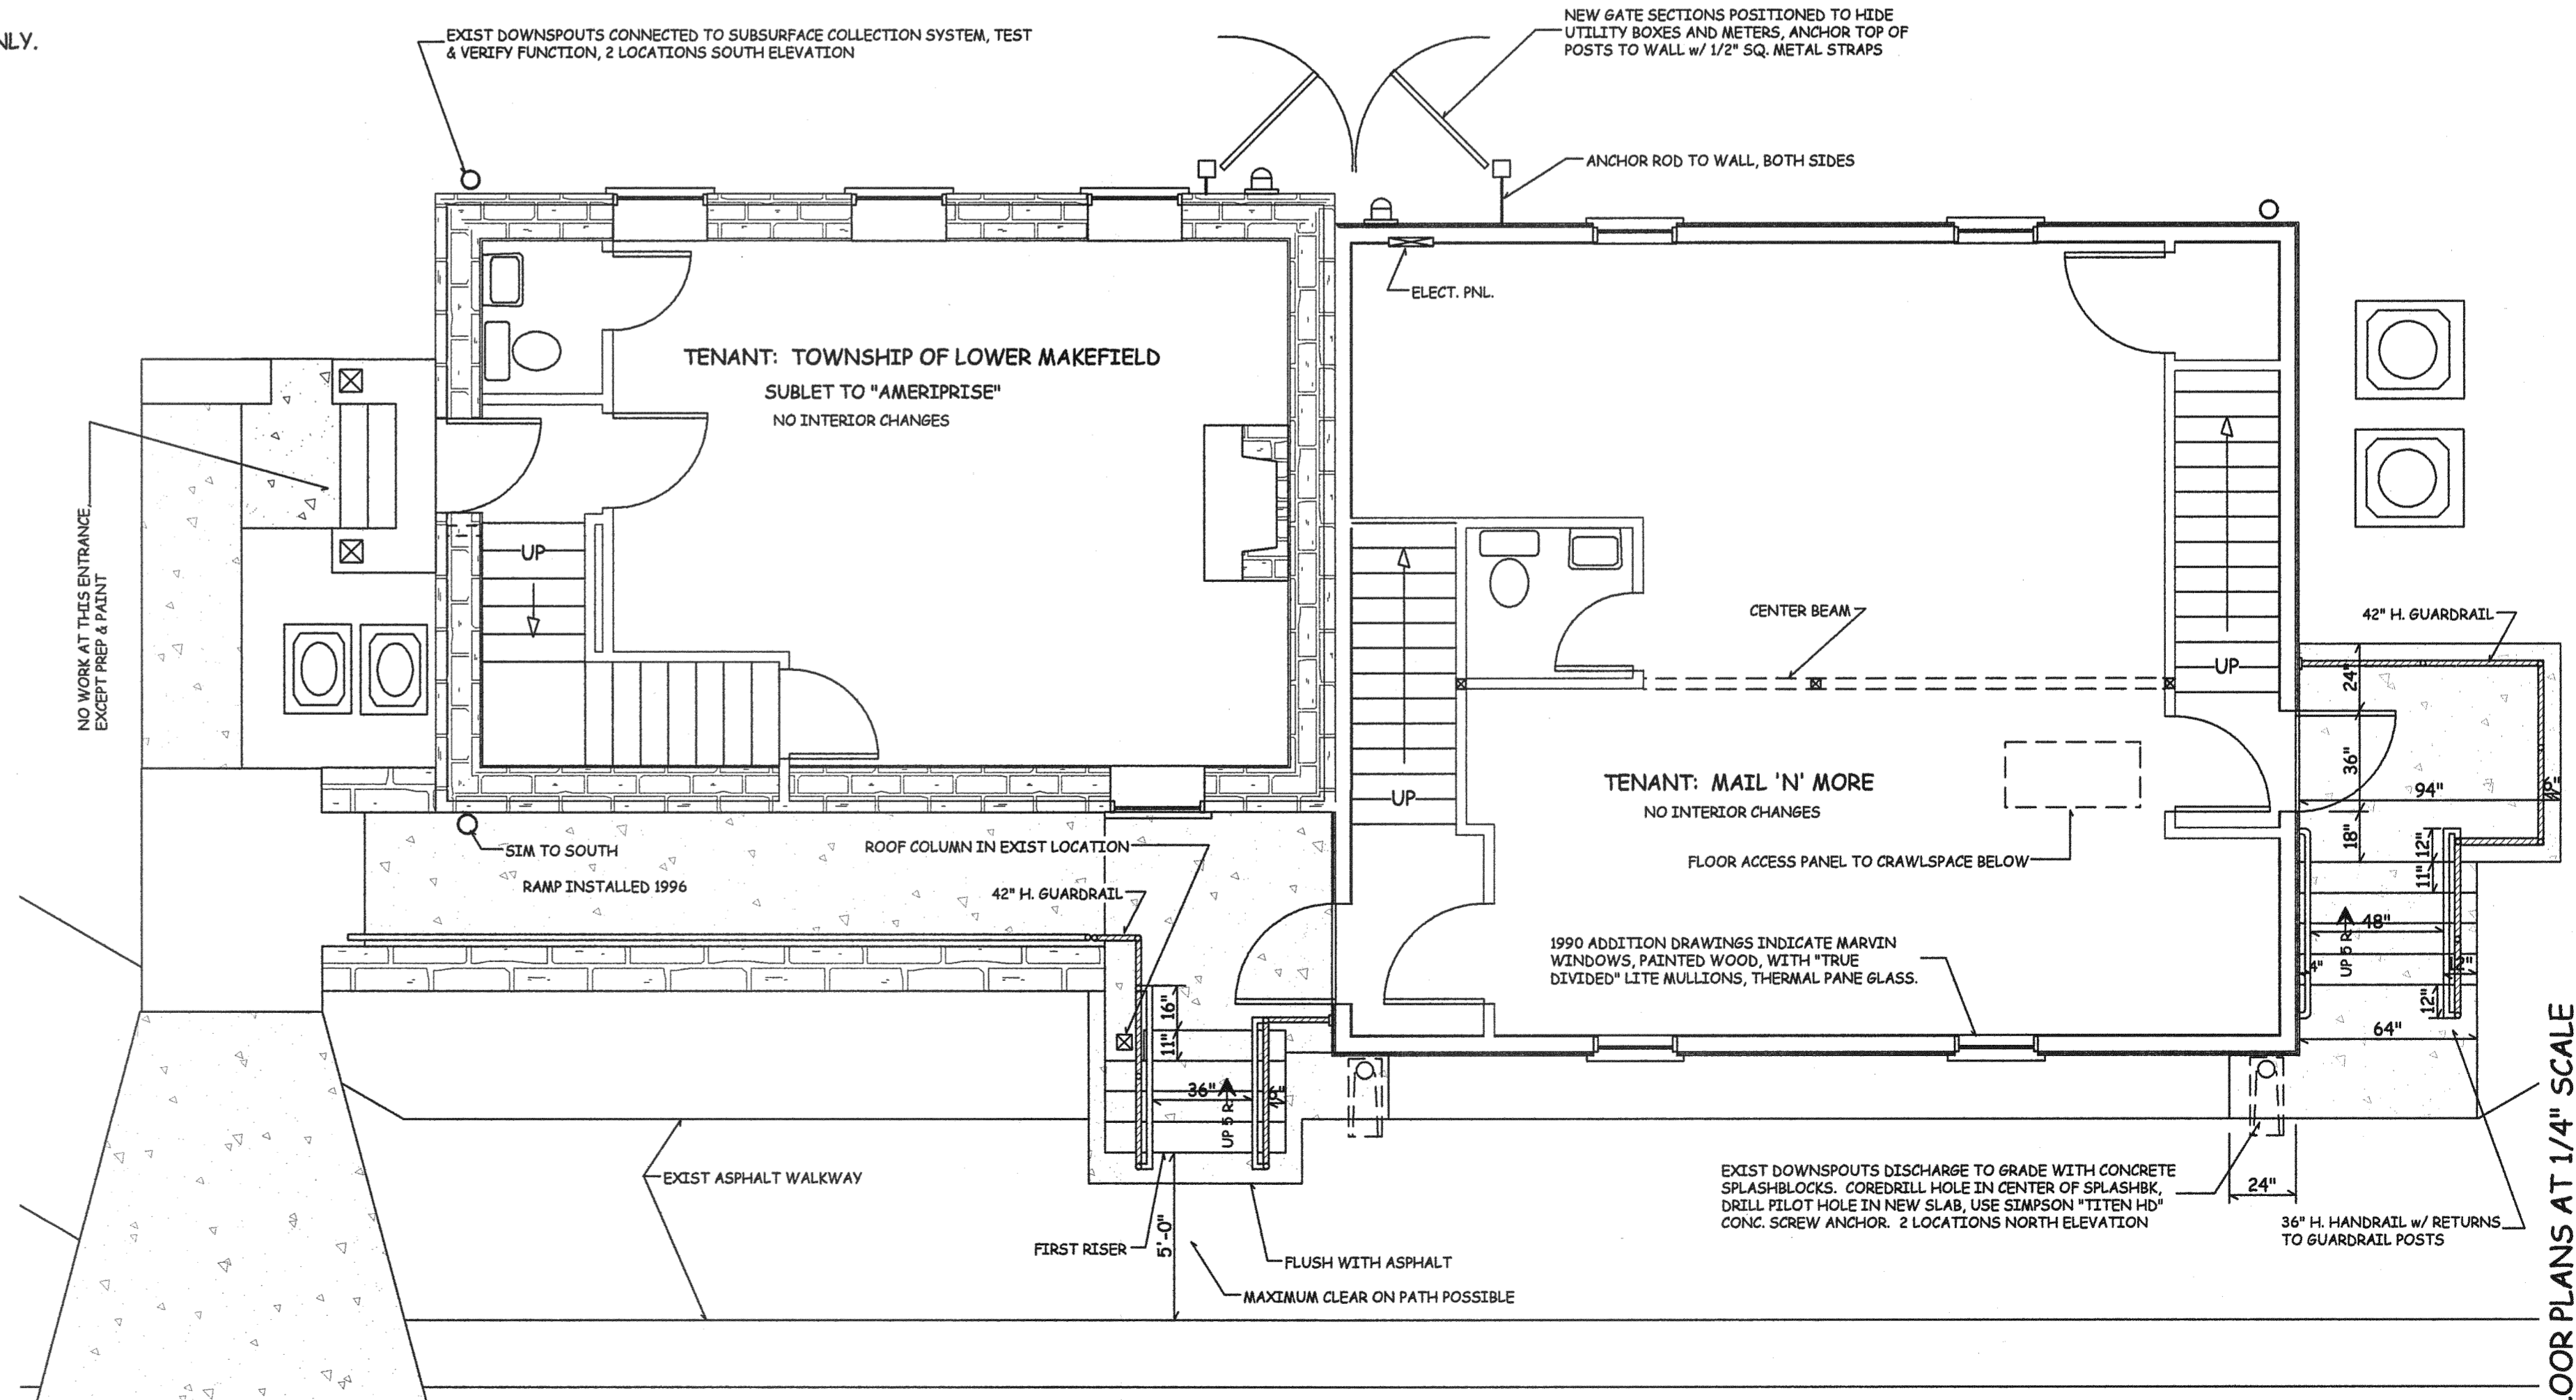

2
2 GROUND (FIRST) FLOOR PLAN
 SCALE: 1/4" = 1'-0"

REV. #	REVISION DESCRIPTION	DATE
1	START UP	MAY 21, 2008
2	FOR PERMIT AND HISTORIC REVIEW	FEB. 22, 2011
3	REVISIONS FOR PERMITS REVIEW	APR. 04, 2011

VALID FOR PERMITS ONLY WITH EMBOSSED SEAL & ORIGINAL SIGNATURE IN RED

D. Wesley Rapp
 General Contracting & Building
 525 Davisville Road
 Willow Grove, PA 19090
 Voice: 215-657-6083
 Fax: 215-657-8018

Eric C. Van Reed, Architect
 Creative Design Assoc. Inc.
 ARCHITECTURE, INTERIORS, SITE & SPACE PLANNING
 350 Callowhill Road
 Chalfont, PA 18914
 Voice: 215-672-1155
 www.ArchitectVision.com

Lower Makefield Center
 Warren Farringer House-Repairs
 LOWER MAKEFIELD TWP., BUCKS CO., PA